


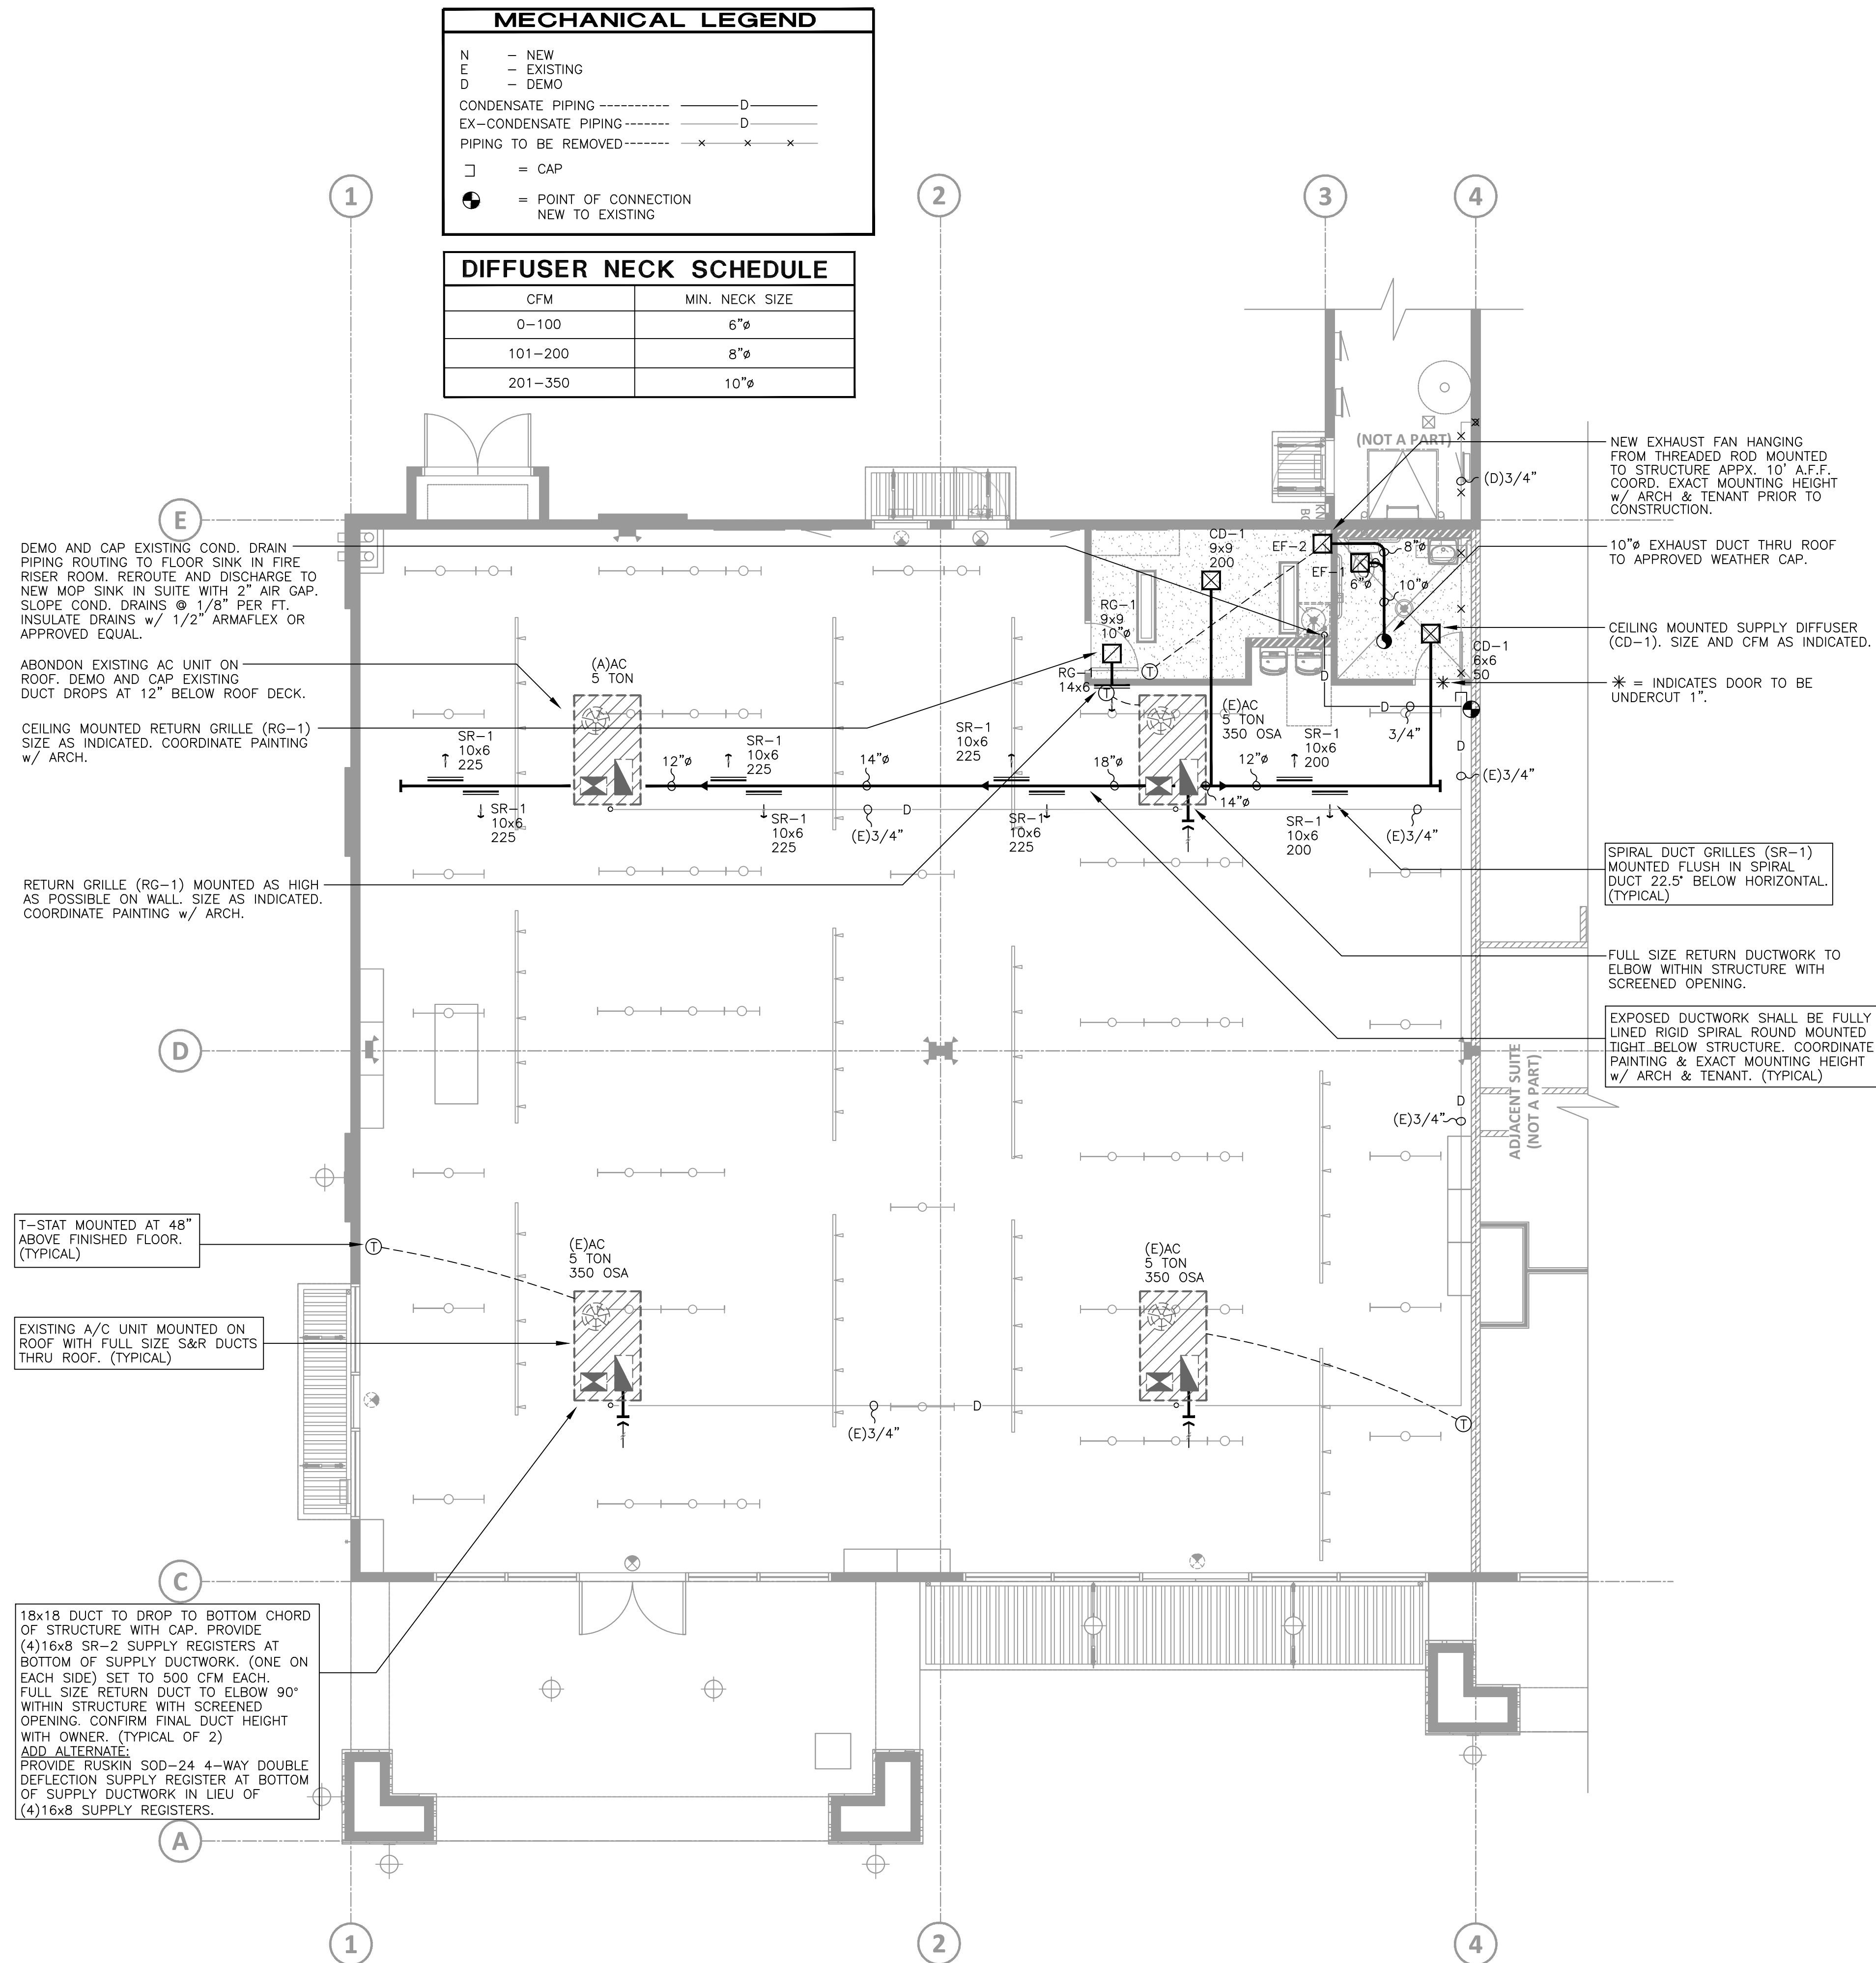


MECHANICAL FLOOR PLAN
3/16"=1'-0" NORTH

5635 E. Thomas Road Phoenix, AZ 85018
Job No. 21339
Consulting Engineers
Phone (602) 943-6608
Web: MechDesigns.com



IRKAA
ARCHITECTS
2233 EAST THOMAS ROAD, PHOENIX, ARIZONA 85016
602-955-3900
RCAA.COM

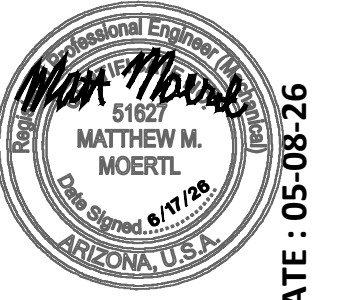

MECHANICAL FLOOR PLAN

NOTICE OF ALTERNATE BILLING OR PAYMENT CYCLE:
THIS CONTRACT MAY ALLOW THE OWNER TO REQUIRE THE SUBMISSION OF BILLING OR ESTIMATES IN BILLING CYCLES OTHER THAN THIRTY DAYS. THIS CONTRACT MAY ALLOW OWNER TO MAKE PAYMENT IN 15 DAY BILLS. THE 15 DAY BILL AFTER CERTIFICATION AND APPROVAL OF BILLING AND ESTIMATES. A WRITTEN DESCRIPTION OF SUCH BILLING CYCLE APPLICABLE TO THE PROJECT IS AVAILABLE FROM OWNER OR DESIGNATED AGENT.
NAME: _____
ADDRESS: _____
PHONE: _____

BROOKLYN BEDDING
PAD 5B - SUITES 101 AND 102 AT PASEO LINDO SHOPPING CENTER
NEC OF ARIZONA AVE AND OCOTILLO RD.
CHANDLER, AZ

COPYRIGHT 2023. ALL RIGHTS RESERVED. THIS DRAWING IS AN INSTRUMENT OF SERVICE. IT IS THE PROPERTY OF IRKAA ARCHITECTS, INC. AND MAY NOT BE REPRODUCED, COPIED, OR REPRODUCED IN ANY MANNER WITHOUT WRITTEN PERMISSION OF THE CORPORATION.

design by: MB
drawn by: MB
checked by: JG

M100
project #: 26102.00